

BURGIN CONSTRUCTION INC.

Burgin Construction Design Center
630 S Grand Ave, CA 92705
Phone: 714-558-1094
Fax: 714-835-2101
Email: sales@burginconstructioninc.com

REVISIONS


- 1
- 2

THIS SET OF CONSTRUCTION DOCUMENTS, INCLUDING ALL IDEAS AND DESIGN, ARE MEANS OF PROFESSIONAL SERVICES AS THE PROPERTY OF DAVID MICHAEL DESIGNZ (DMDZ), AND IS NOT TO BE USED IN EITHER ENTIRELY OR PARTIALLY FOR ANY OTHER PROJECTS WITHOUT THE WRITTEN AUTHORIZATION OF DAVID MICHAEL DESIGNZ (DMDZ). THE REPRODUCTION OR MODIFICATION OF THIS DOCUMENT WITHOUT THE PRIOR WRITTEN CONSENT OF DMDZ IS PROHIBITED.
THIS DOCUMENTATION INCLUDES NEW WORK AND DOES NOT NECESSARILY INCLUDE AS-BUILT OR EXISTING CONDITIONS. DMDZ IS NOT WARRANT, IN ANY WAY, THE ACCURACY OF THE INFORMATION, AND SHALL NOT BE RESPONSIBLE FOR ANY DISCREPANCY BETWEEN THIS DOCUMENT AND EXISTING CONDITIONS.


WALL LEGEND & BASIC CALL OUT'S

- DEMO WALLS
- (N) EXTERIOR WALL
- (E) EXTERIOR WALL
- (N) INTERIOR WALL
- (E) INTERIOR WALL
- (N) SQ. FT. AREA

(N) = NEW
(E) = EXISTING
F.F. = FINISHED FLOOR
N.G. = NATURAL GRADE
P.L. = PLATE HEIGHT

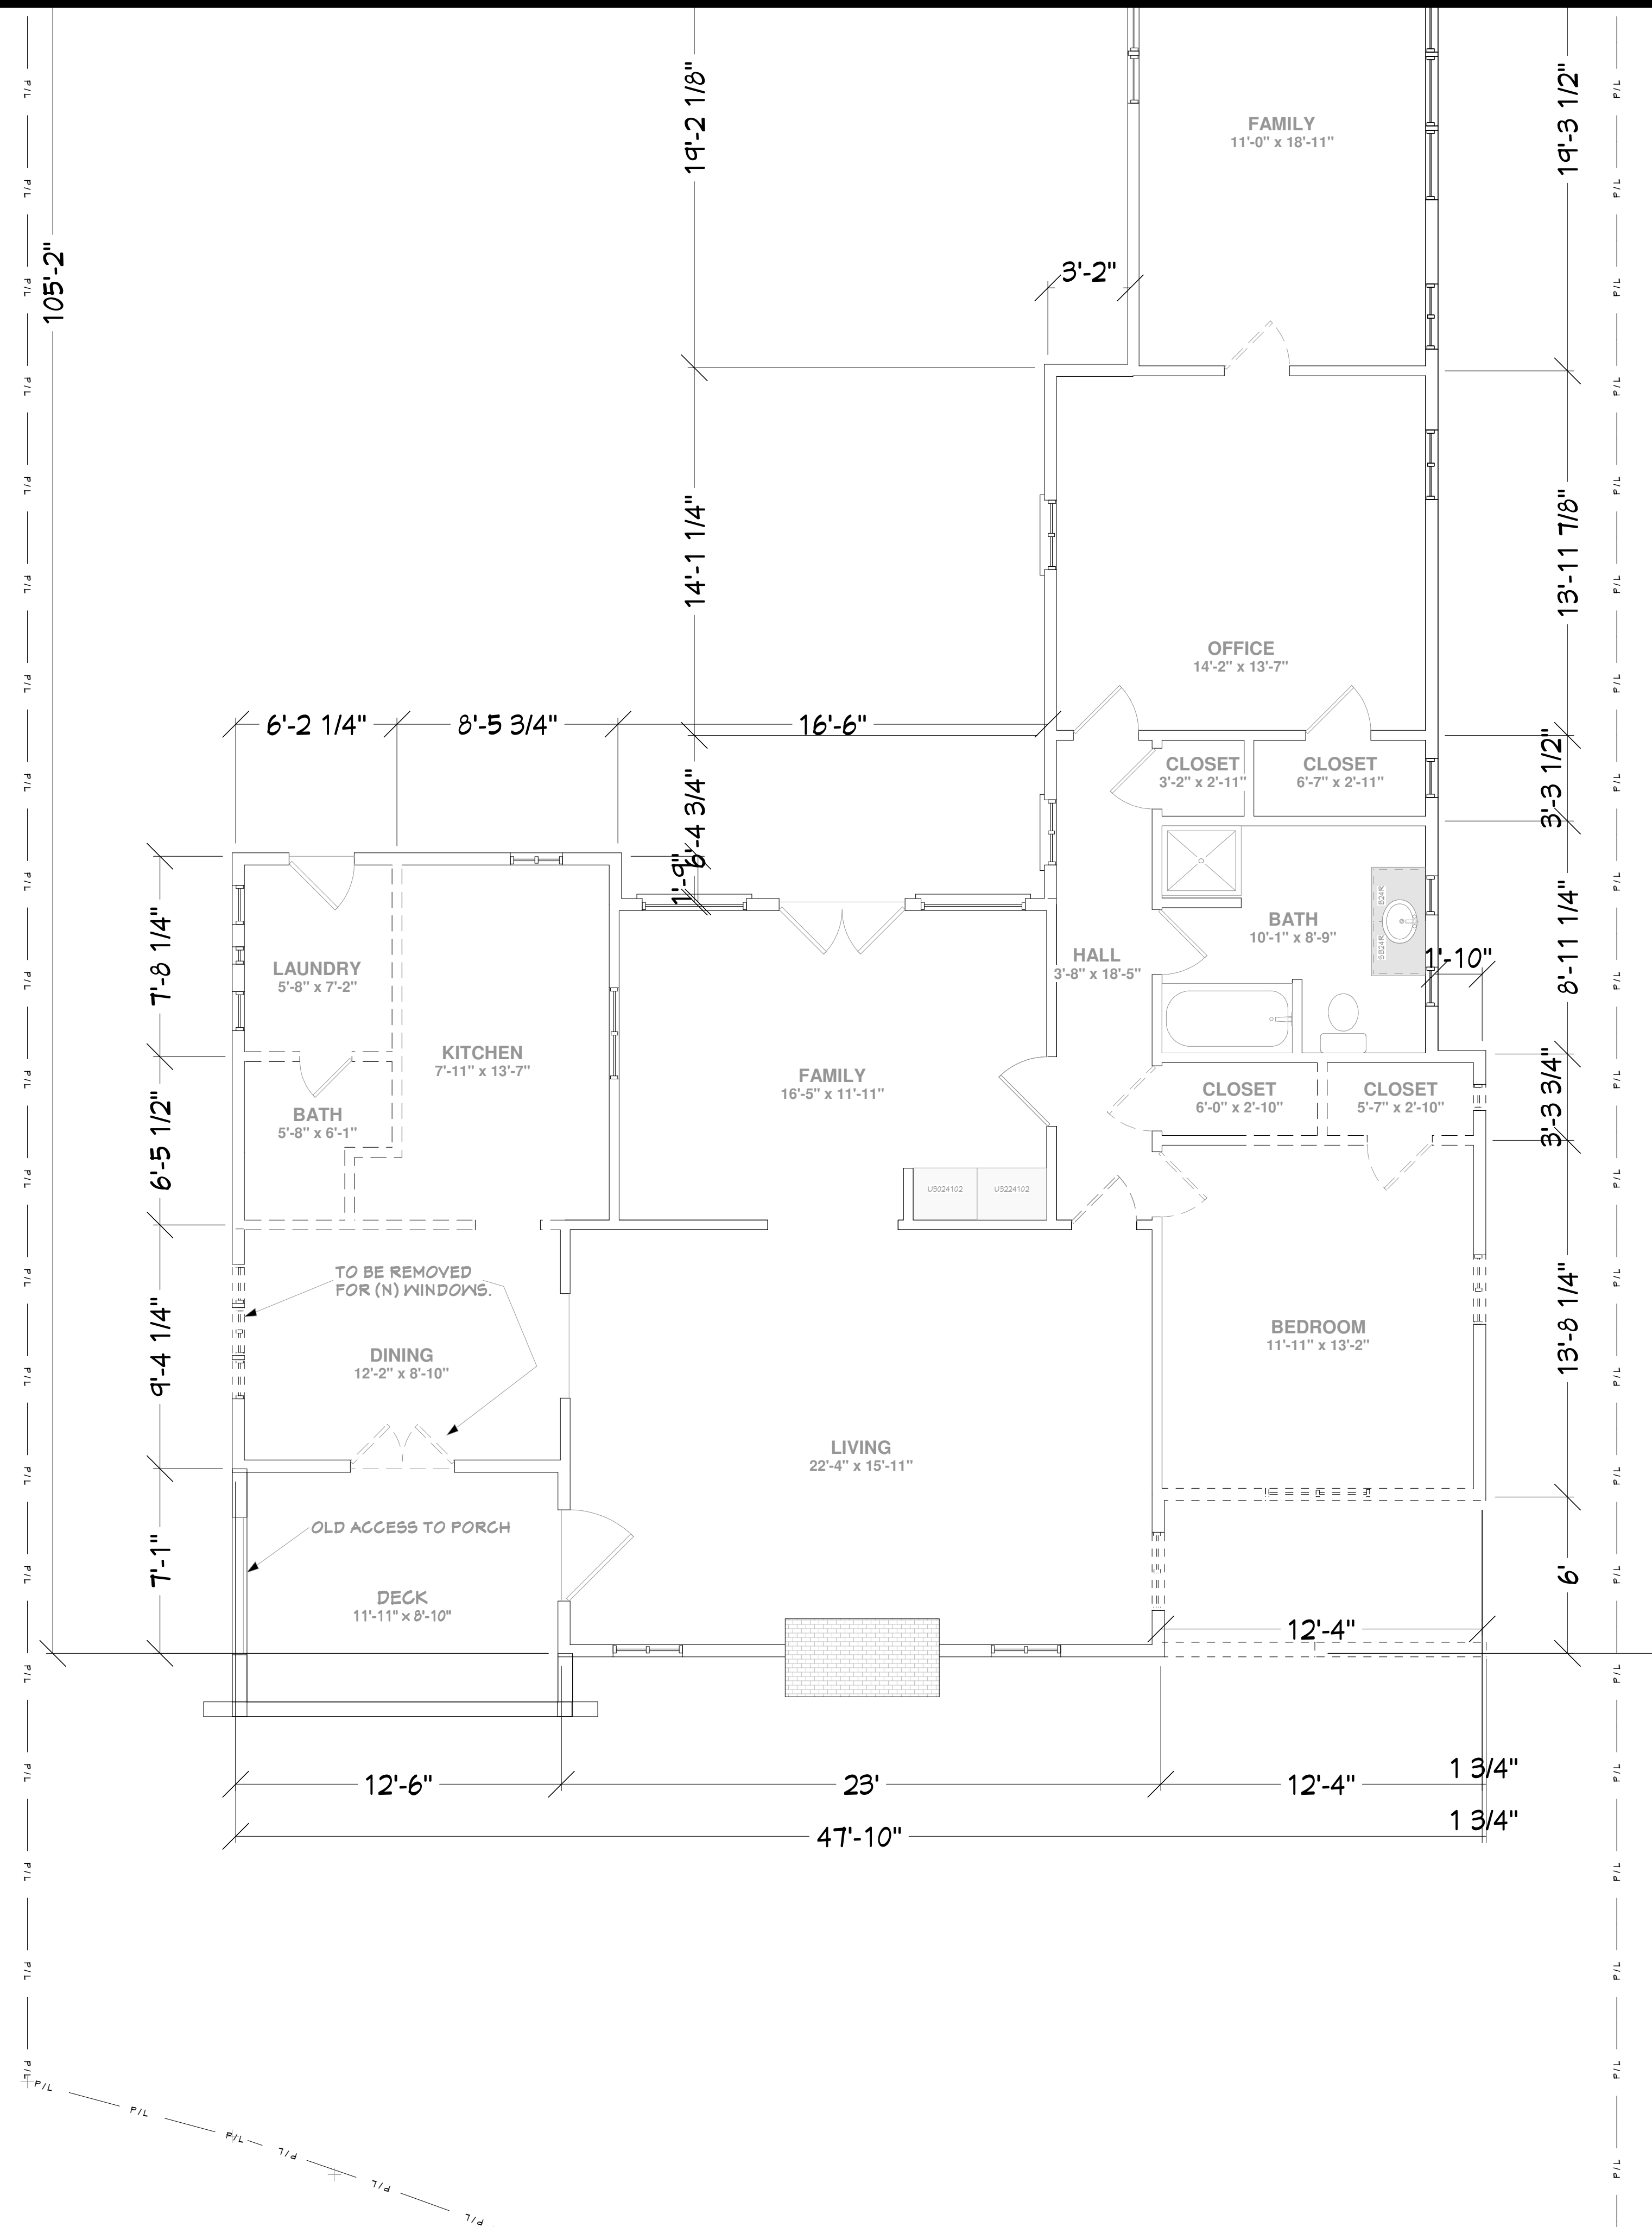

3D PERSPECTIVE OF EXISTING STRUCTURE

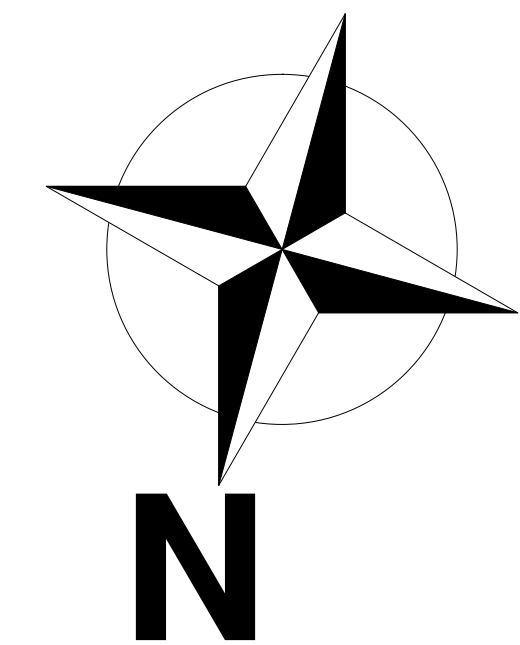

DEMO PLAN

Walt and Jeri Prober
417 El Camino del Mar
Laguna Beach Ca 92651

2	TITLE	
	DATE	5/14/2009
	SCALE	
	ARTIST	DAVID MICHAEL DESIGNZ

SHEET

A2


BURGIN CONSTRUCTION INC.

Burgin Construction Design Center
630 S Grand Ave, CA 92705
Phone: 714-558-1094
Fax: 714-835-2101
Email: sales@burginconstructioninc.com

REVISIONS


- 1
- 2

THIS SET OF CONSTRUCTION DOCUMENTS, INCLUDING ALL IDEAS AND DESIGN, ARE MEANS OF PROFESSIONAL SERVICES AS THE PROPERTY OF DAVID MICHAEL DESIGNZ (DMDZ), AND IS NOT TO BE USED IN EITHER ENTIRELY OR PARTIALLY FOR ANY OTHER PROJECTS WITHOUT THE WRITTEN AUTHORIZATION OF DAVID MICHAEL DESIGNZ (DMDZ). THE REPRODUCTION OR MODIFICATION OF THIS DOCUMENT WITHOUT THE PRIOR WRITTEN CONSENT OF DMDZ IS PROHIBITED. THIS DOCUMENTATION INCLUDES NEW WORK AND DOES NOT NECESSARILY INCLUDE AS-BUILT OR EXISTING CONDITIONS. DMDZ IS NOT WARRANT, IN ANY WAY, THE ACCURACY OF THIS INFORMATION, AND SHALL NOT BE RESPONSIBLE FOR ANY DISCREPANCY BETWEEN THIS DOCUMENT AND EXISTING CONDITIONS.

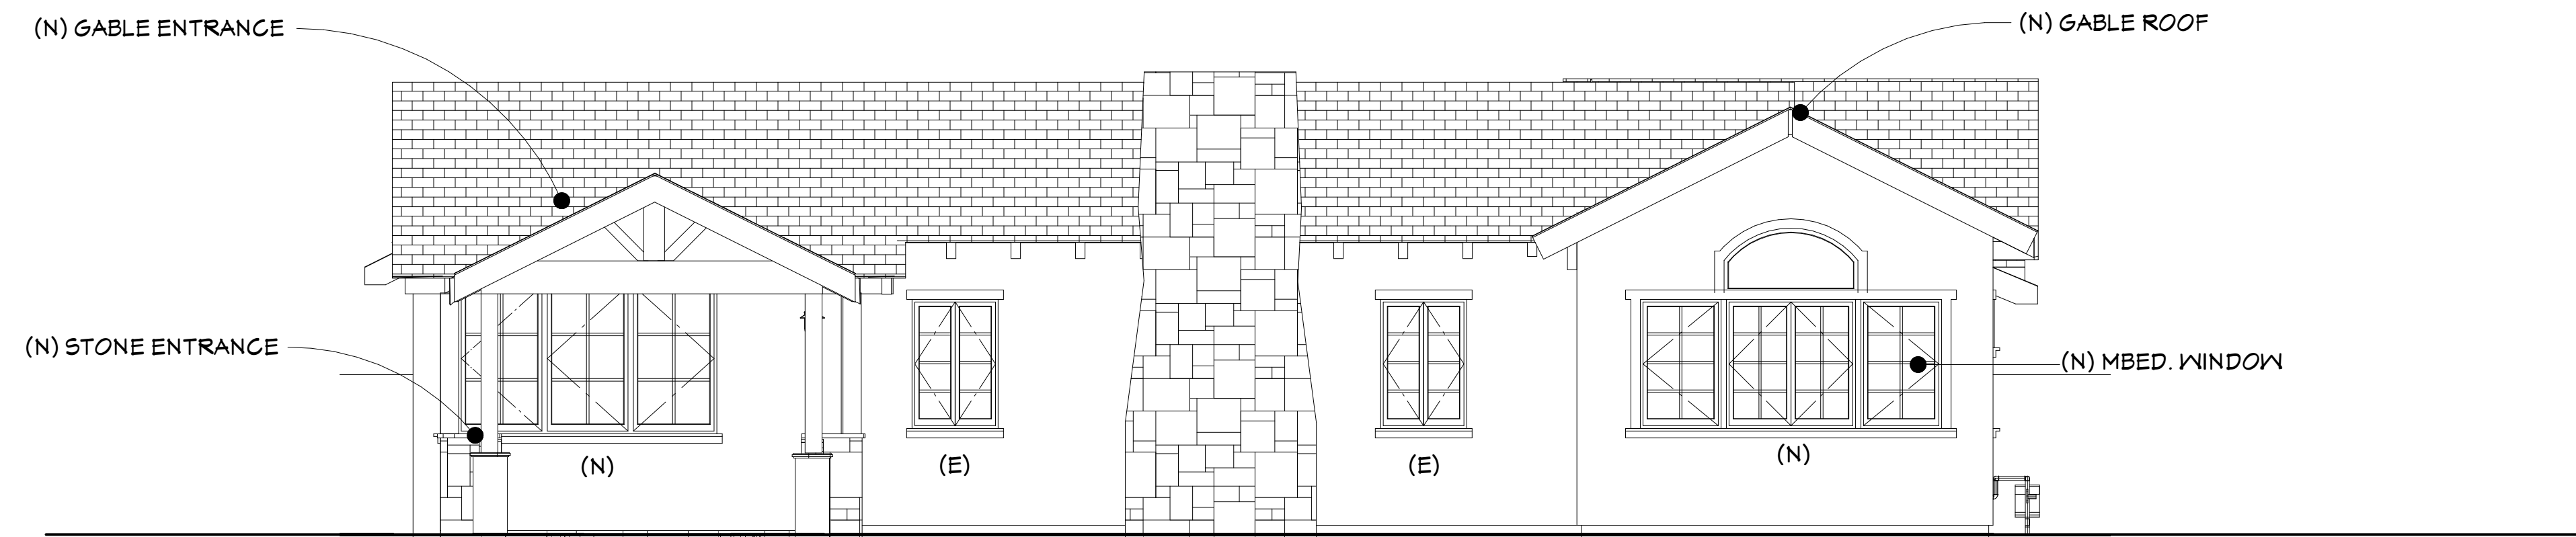

FRONT ELEVATION

SCALE: 1/4" = 1'-0"

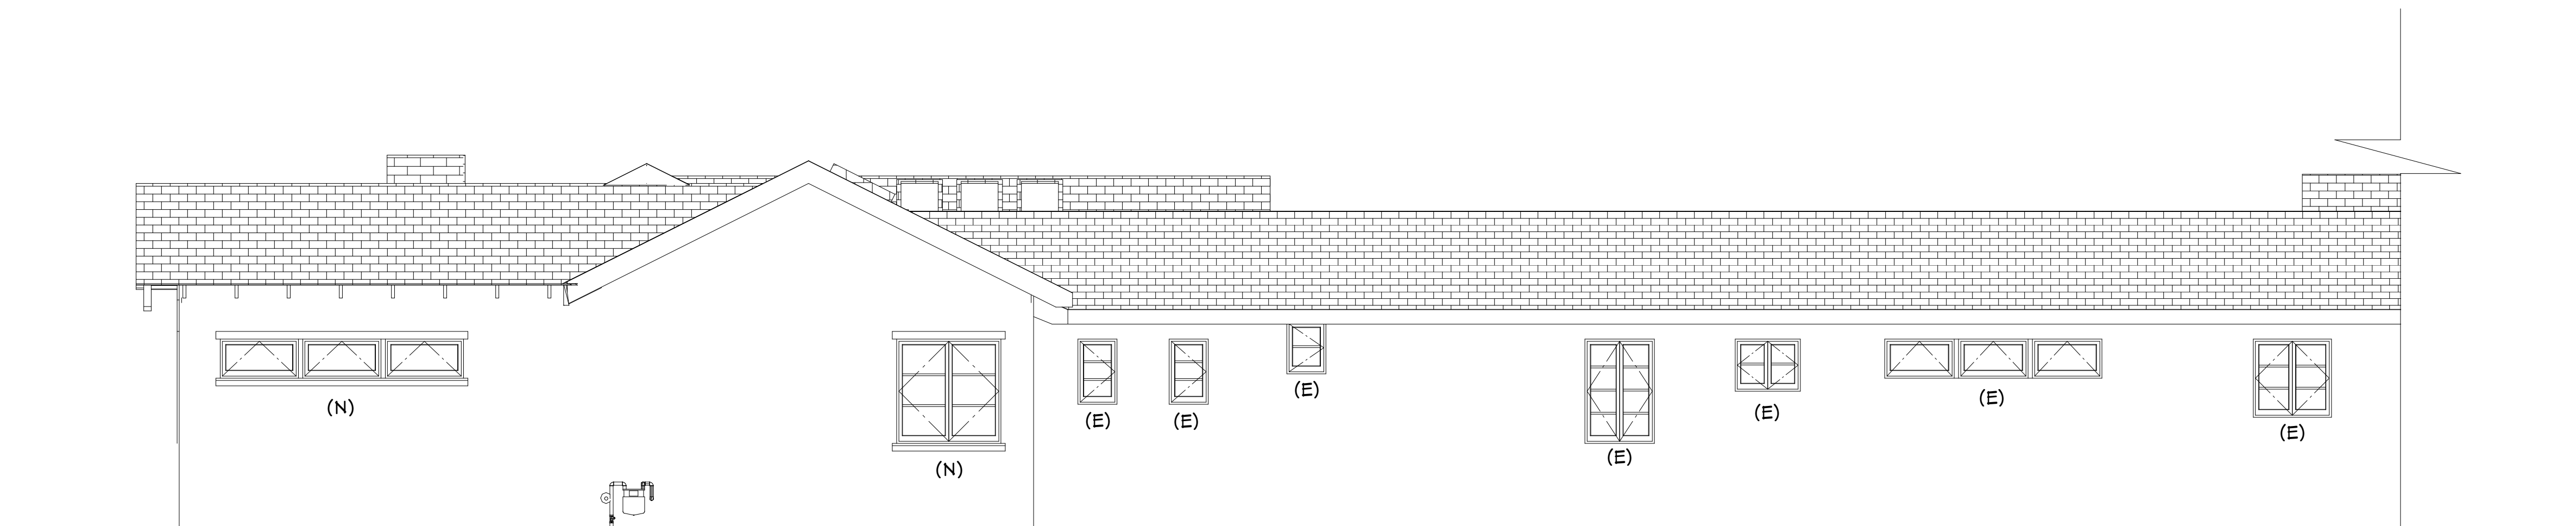

RIGHT ELEVATION

SCALE: 1/4" = 1'-0"



LEFT ELEVATION

SCALE: 1/4" = 1'-0"

Walt and Jeri Prober
417 El Camino del Mar
Laguna Beach Ca 92651

4	TITLE
	DATE 5/14/2009
	SCALE
	ARTIST DAVID MICHAEL DESIGNS

SHEET

A4

ELEVATIONS


BURGIN CONSTRUCTION INC.

Burgin Construction Design Center
630 S Grand Ave, CA 92705
Phone: 714-558-1094
Fax: 714-835-2101
Email: sales@burginconstructioninc.com

REVISIONS

- 1
- 2


THIS SET OF CONSTRUCTION DOCUMENTS, INCLUDING ALL IDEAS AND DESIGN, ARE MEANS OF PROFESSIONAL SERVICES AS THE PROPERTY OF DAVID MICHAEL DESIGN (DMD), AND IS NOT TO BE USED IN EITHER ENTIRELY OR PARTIALLY FOR ANY OTHER PROJECTS WITHOUT THE WRITTEN AUTHORIZATION OF DAVID MICHAEL DESIGN (DMD). THE REPRODUCTION OR MODIFICATION OF THIS DOCUMENT WITHOUT THE PRIOR WRITTEN CONSENT OF DMD IS PROHIBITED.
THIS DOCUMENTATION INCLUDES NEW WORK AND DOES NOT NECESSARILY INCLUDE AS-BUILT OR EXISTING CONDITIONS. DMD IS NOT WARRANT, IN ANY WAY, THE ACCURACY OF THIS INFORMATION, AND SHALL NOT BE RESPONSIBLE FOR ANY DISCREPANCY BETWEEN THIS DOCUMENT AND EXISTING CONDITIONS.

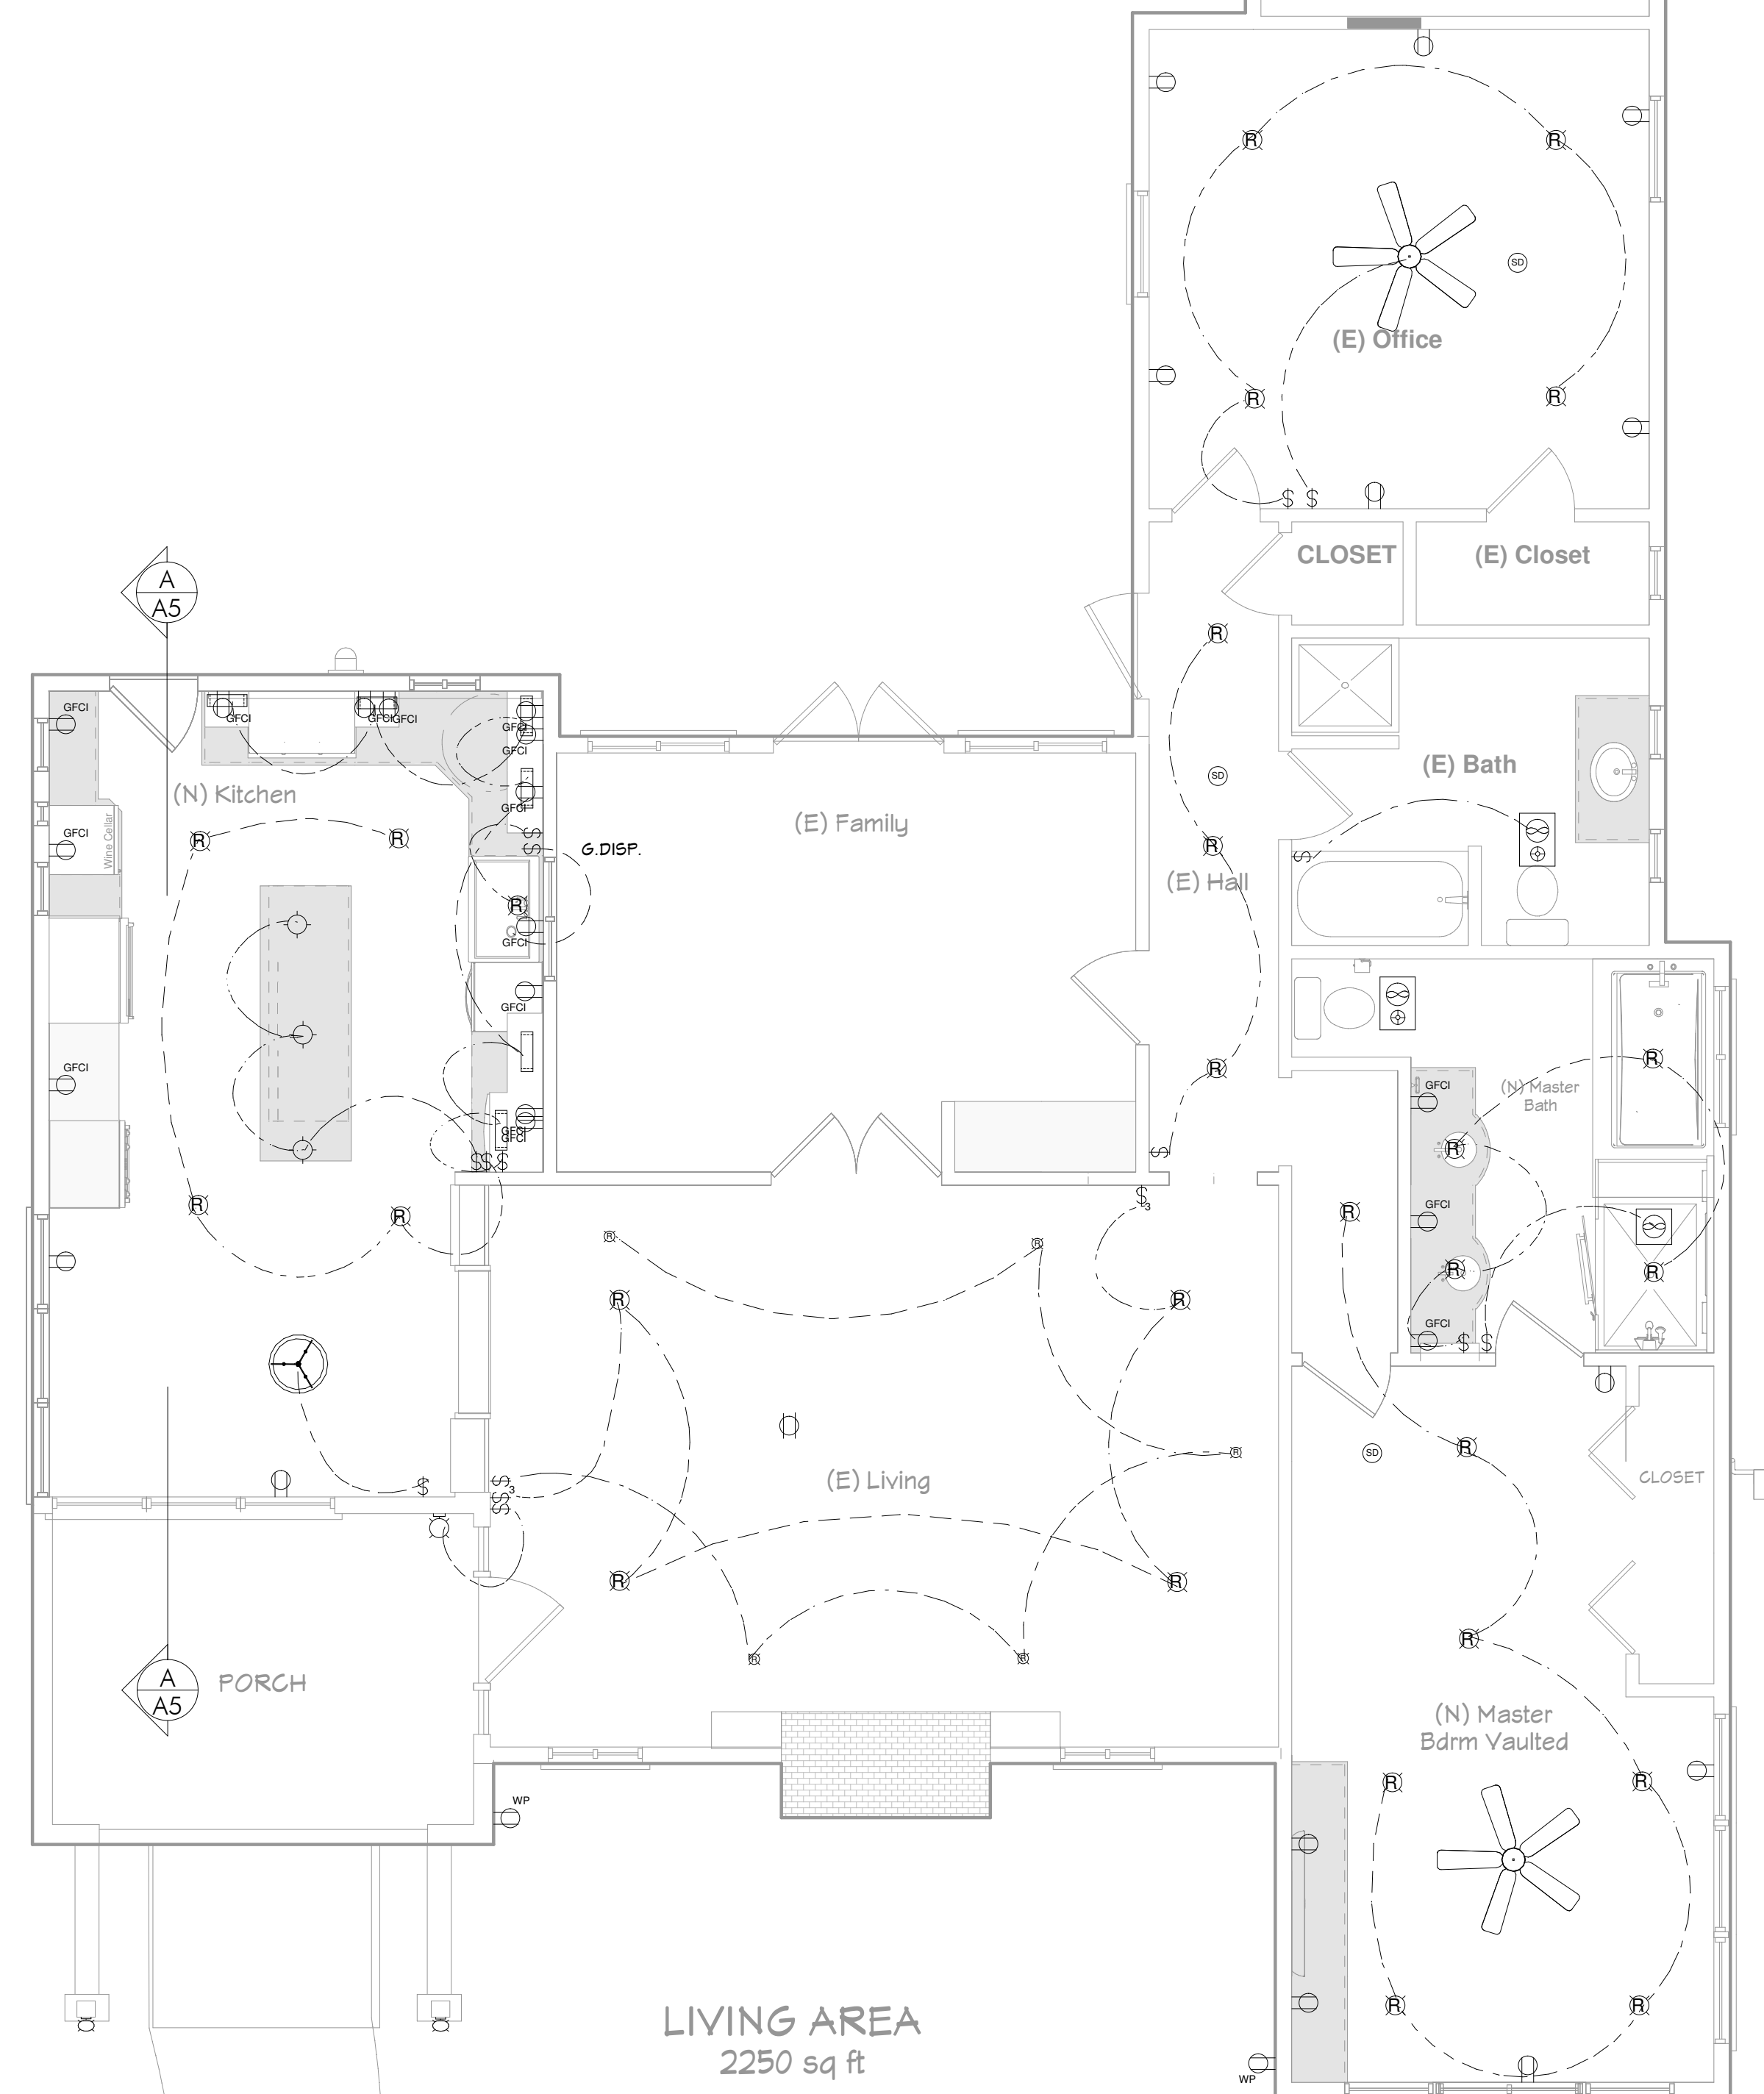

ELECTRICAL SCHEDULE							
NUMBER	QTY	FLOOR	WIDTH	DEPTH	HEIGHT	ATTACHED TO	DESCRIPTION
E01	1	1	10 11/16"	10 11/16"	60 3/8"	CEILING MOUNT	SCROLL PENDANT - METAL COPPER (POLISHED)
E02	2	1	10 11/16"	10 11/16"	60 1/2"	CEILING MOUNT	SCROLL PENDANT - METAL COPPER (POLISHED)
E04	1	1	20"	19 11/16"	44 15/16"	CEILING MOUNT	BOWL PENDANT CHANDELIER - LIGHTING YELLOW
E05	14	1	3"	3/4"	5"	WALL MOUNT	SINGLE POLE
E06	13	1	3"	5/16"	5"	WALL MOUNT	DUPLEX
E07	16	1	3"	5/16"	5"	WALL MOUNT	GFCI
E08	2	1	48 7/16"	50 3/4"	19"	CEILING MOUNT	MEDITERRANIAN - HIGHRES WALNUT SHEET
E09	27	1	7 5/16"	7 5/16"	3/16"	CEILING MOUNT	RECESSED LIGHT
E10	1	1	9"	9 1/4"	18 5/16"	WALL MOUNT	CAGED LANTERN
E11	2	1	12"	18"	1 1/4"	CEILING MOUNT	EXHAUST (HEAT LAMP)
E12	1	1	12"	12"	1 1/4"	CEILING MOUNT	EXHAUST
E13	3	1	5"	5"	1 1/8"	CEILING MOUNT	SMOKE DETECTOR
E14	5	1	4 1/2"	4 1/2"	4 1/8"	CEILING MOUNT	EYEBALL (ROTATED)
E15	2	1	3"	3/4"	5"	WALL MOUNT	THREE WAY
E16	6	1	13 1/2"	4"	1 3/8"		ROUNDED
E17	1	1	3"	4 3/4"	3/16"	FLOOR MOUNT	DUPLEX
E18	2	1	3"	3/4"	5"	WALL MOUNT	DUPLEX (WEATHERPROOF) - COLOR LIGHT GRAY (MATTE)
E19	2	1	6"	4"	12"	WALL MOUNT	MINER'S SCORCE - COLOR - GRAPHITE

ELECTRICAL - DATA - AUDIO LEGEND

SYMBOL	DESCRIPTION
	Ceiling Fan
	Ventilation Fans: Ceiling Mounted, Wall Mounted
	Ceiling Mounted Light Fixtures: Surface/Pendant, Recessed, Heat Lamp, Low Voltage
	Wall Mounted Light Fixtures: Flush Mounted, Wall Sconce
	Chandelier Light Fixture
	Fluorescent Light Fixture
	240V Receptacle
	110V Receptacles: Duplex, Weather Proof, GFCI
	Switches: Single Pole, Weather Proof, 3-Way, 4-Way
	Switches: Dimmer, Timer
	Audio Video: Control Panel, Switch
	Speakers: Ceiling Mounted, Wall Mounted
	Wall Jacks: CAT5, CAT5 + TV, TV/Cable
	Telephone Jack
	Intercom
	Thermostat
	Door Chime, Door Bell Button
	Smoke Detectors: Ceiling Mounted, Wall Mounted
	Electrical Breaker Panel

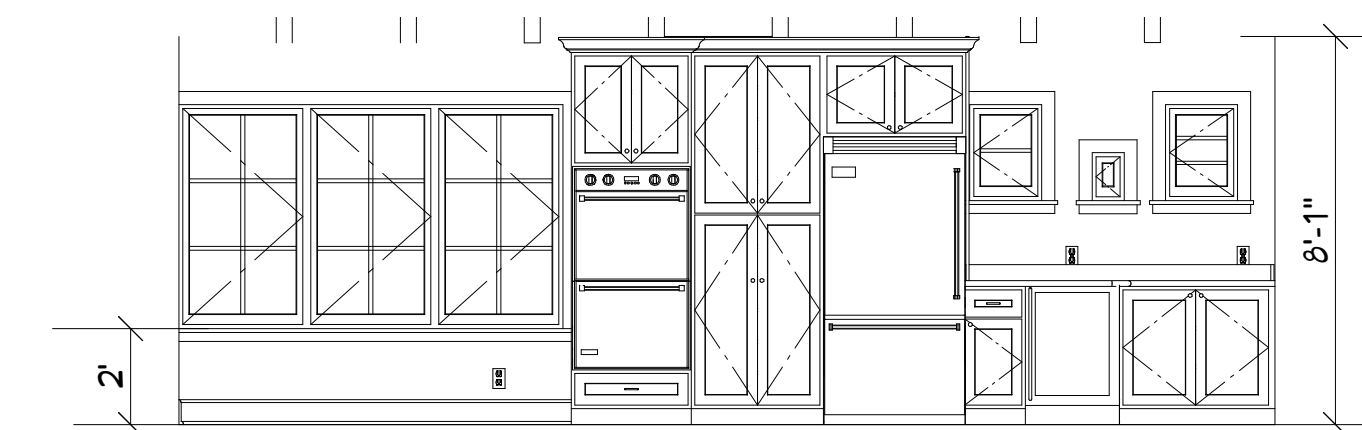

CROSS SECTION "A"

SCALE: 1/4" = 1'-0"

Walt and Jeri Prober
417 El Camino del Mar
Laguna Beach Ca 92651

5	TITLE
	DATE 5/14/2009
	SCALE
	ARTIST DAVID MICHAEL DESIGNS

SHEET

A5


BURGIN CONSTRUCTION INC.

Burgin Construction Design Center
630 S Grand Ave, CA 92705
Phone: 714-558-1094
Fax: 714-835-2101
Email: sales@burginconstructioninc.com

REVISIONS

- 1
- 2

THIS SET OF CONSTRUCTION DOCUMENTS, INCLUDING ALL IDEAS AND DESIGN, ARE MEANS OF PROFESSIONAL SERVICES AS THE PROPERTY OF DAVID MICHAEL DESIGN (DMD), AND IS NOT TO BE USED IN EITHER ENTIRELY OR PARTIALLY FOR ANY OTHER PROJECTS WITHOUT THE WRITTEN AUTHORIZATION OF DAVID MICHAEL DESIGN (DMD). THE REPRODUCTION OR MODIFICATION OF THIS DOCUMENT WITHOUT THE PRIOR WRITTEN CONSENT OF DMD IS PROHIBITED.
THIS DOCUMENTATION INCLUDES NEW WORK AND DOES NOT NECESSARILY INCLUDE AS-BUILT OR EXISTING CONDITIONS. DMD IS NOT WARRANT, IN ANY WAY, THE ACCURACY OF THIS INFORMATION, AND SHALL NOT BE RESPONSIBLE FOR ANY DISCREPANCY BETWEEN THIS DOCUMENT AND EXISTING CONDITIONS.

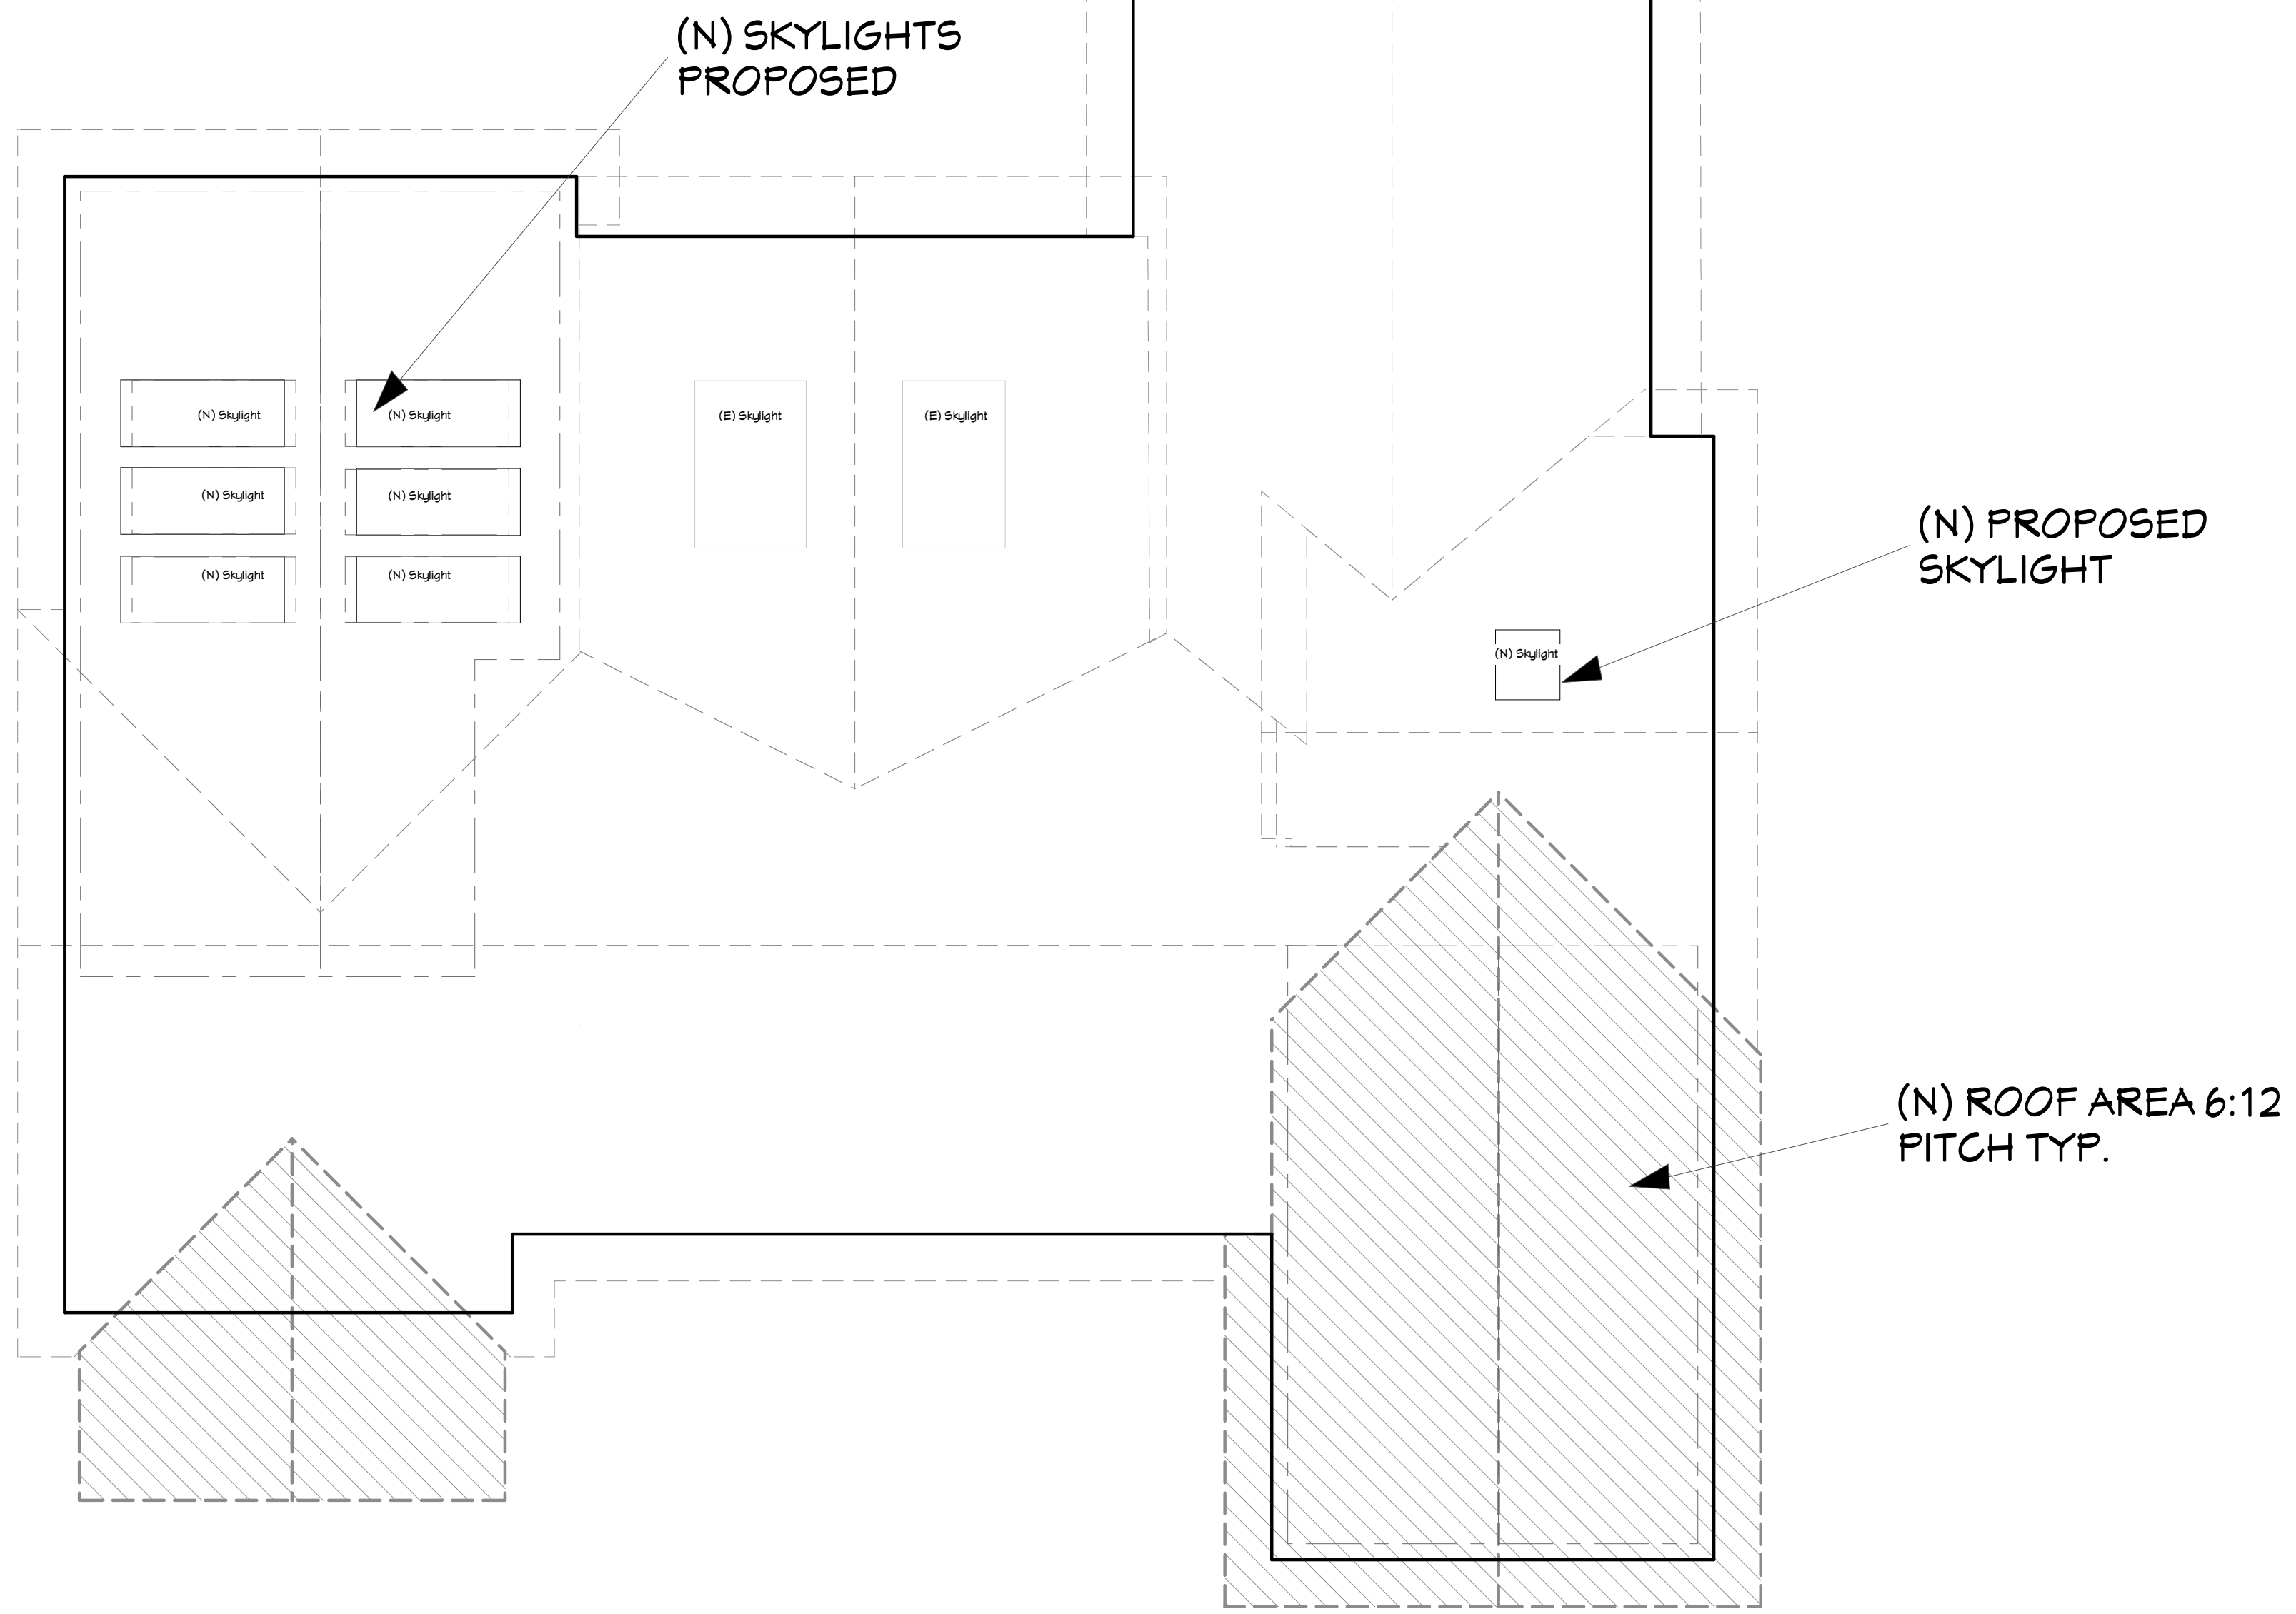


Walt and Jeri Prober
417 El Camino del Mar
Laguna Beach Ca 92651

6	
TITLE	
DATE	5/14/2009
SCALE	
ARTIST	
DAVID MICHAEL DESIGNS	

SHEET

A6

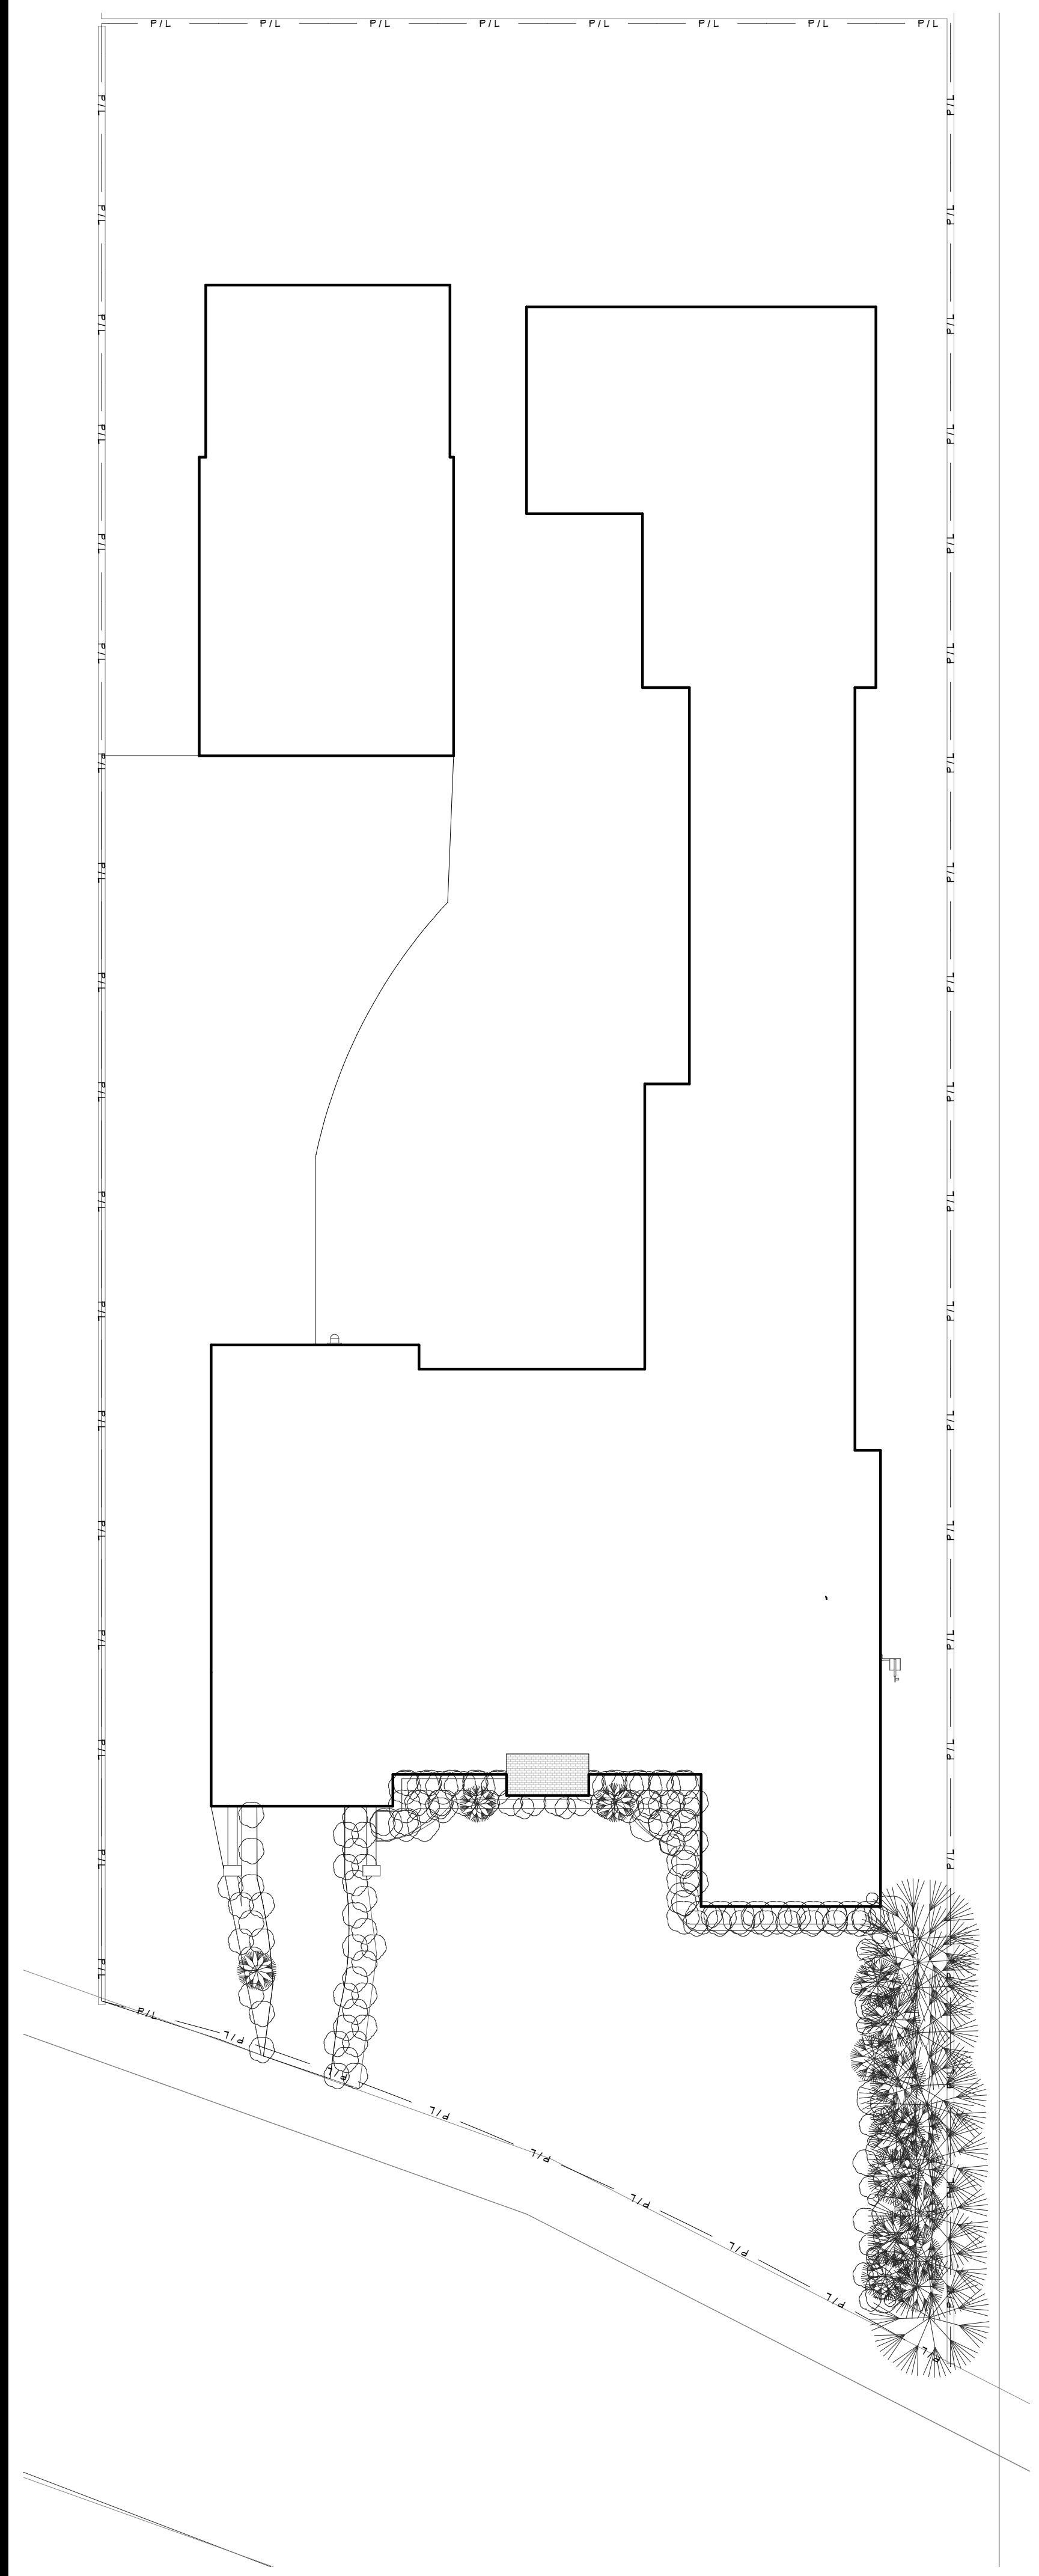

BURGIN CONSTRUCTION INC.

Burgin Construction Design Center
 630 S Grand Ave, CA 92705
 Phone: 714-558-1094
 Fax: 714-835-2101
 Email: sales@burginconstructioninc.com

REVISIONS

- 1
- 2

THIS SET OF CONSTRUCTION DOCUMENTS, INCLUDING ALL IDEAS AND DESIGN, ARE MEANS OF PROFESSIONAL SERVICES AS THE PROPERTY OF DAVID MICHAEL DESIGNZ (DMDZ), AND IS NOT TO BE USED IN EITHER ENTIRELY OR PARTIALLY FOR ANY OTHER PROJECTS WITHOUT THE WRITTEN AUTHORIZATION OF DAVID MICHAEL DESIGNZ (DMDZ). THE REPRODUCTION OR MODIFICATION OF THIS DOCUMENT WITHOUT THE PRIOR WRITTEN CONSENT OF DMDZ IS PROHIBITED.
 THIS DOCUMENTATION INCLUDES NEW WORK AND DOES NOT NECESSARILY INCLUDE AS-BUILT OR EXISTING CONDITIONS. DMDZ IS NOT WARRANT, IN ANY WAY, THE ACCURACY OF THIS INFORMATION, AND SHALL NOT BE RESPONSIBLE FOR ANY DISCREPANCY BETWEEN THIS DOCUMENT AND EXISTING CONDITIONS.

Walt and Jeri Prober
 417 El Camino del Mar
 Laguna Beach Ca 92651

7	
TITLE	
DATE	5/14/2009
SCALE	
ARTIST	
DAVID MICHAEL DESIGNS	

SHEET

A7